


EXAMPLE SET - DO NOT COPY

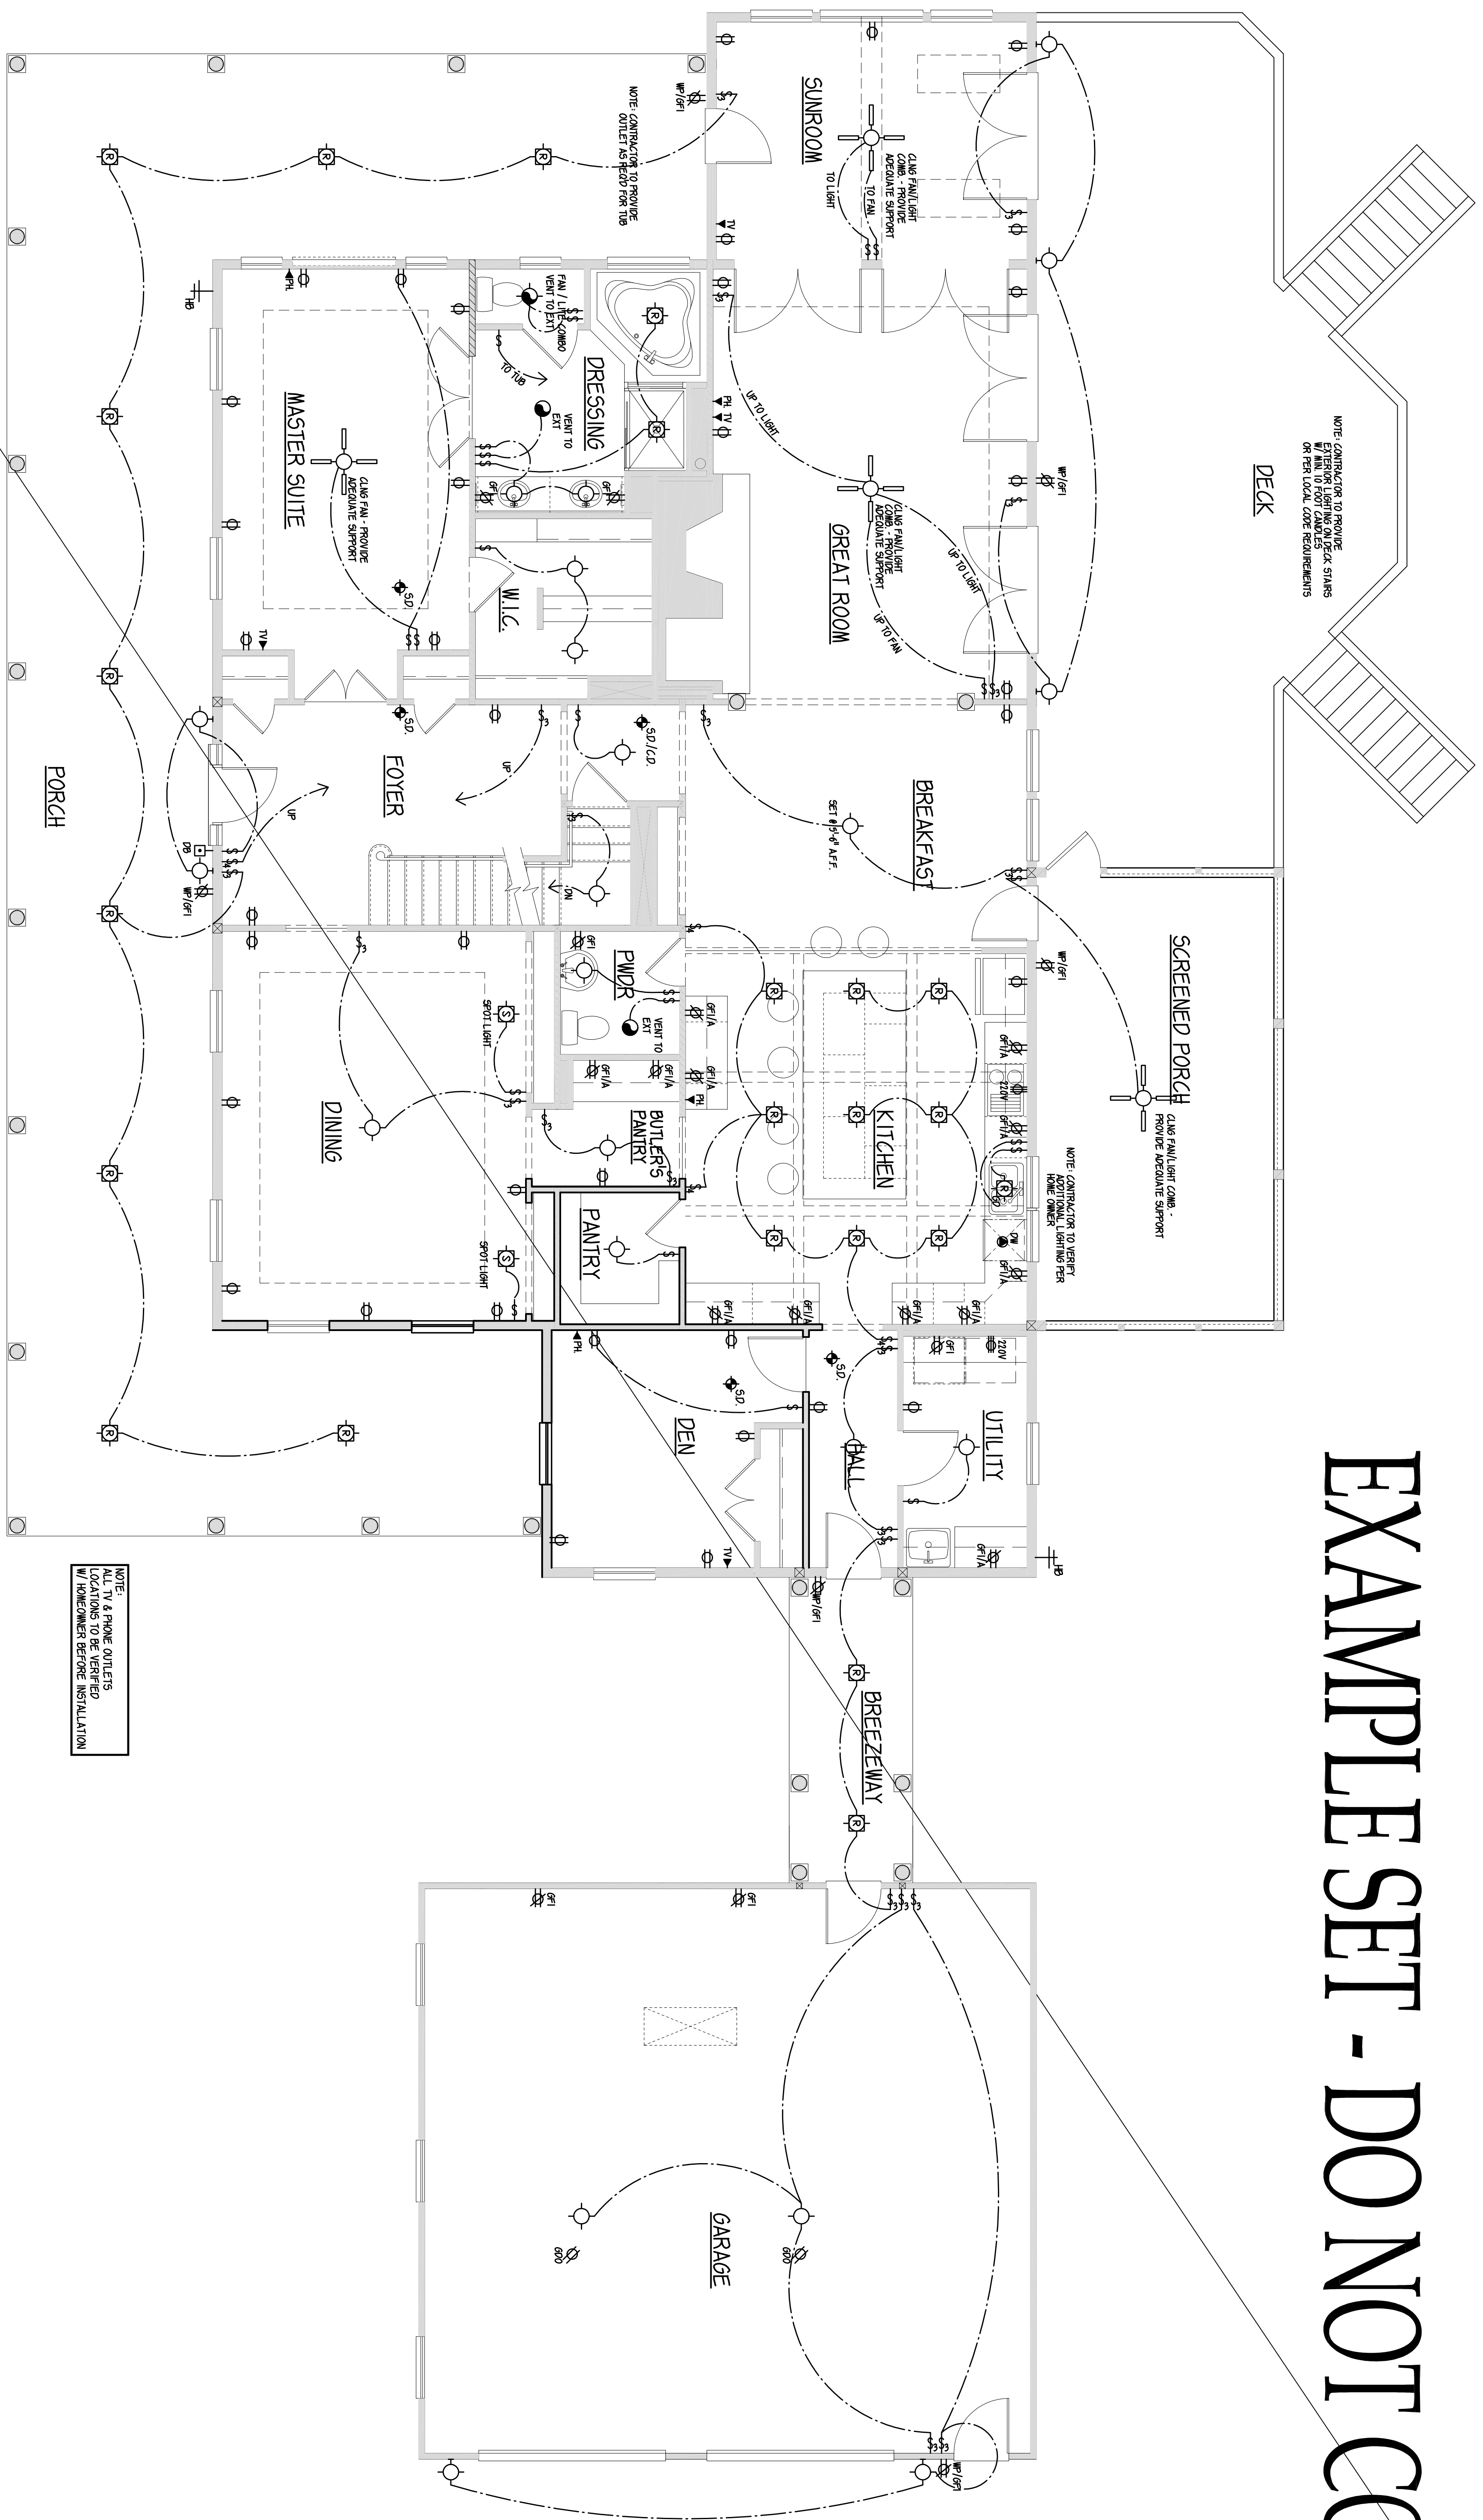

FIRST FLOOR ELECTRICAL PLAN
SCALE: 1/4" = 1'-0"

NOTE:
ALL TV & PHONE OUTLETS
LOCATIONS TO BE VERIFIED
W/ HOMEOWNER BEFORE INSTALLATION

REVISIONS	
DATE:	DATE:
NOTES:	NOTES:
DATE:	DATE:
NOTES:	NOTES:

VOGEL DRAFTING INC.
 RESIDENTIAL DRAFTING SERVICES
 11410 FOREST WALK DR. SPOTSVILVANIA, VA 22533
 540-977-412 PHONE - 540-972-8971 FAX
 WWW.VOGELDRAFTING.COM

EXAMPLE SET
 FIRST FLOOR ELECTRICAL PLAN

NOTES:	8.01
CLIENT:	
FILE NAME:	
DATE:	
DRAFTER:	

SHEET